


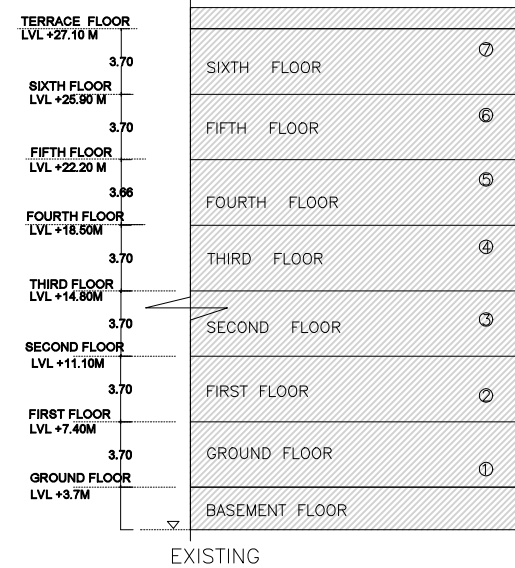


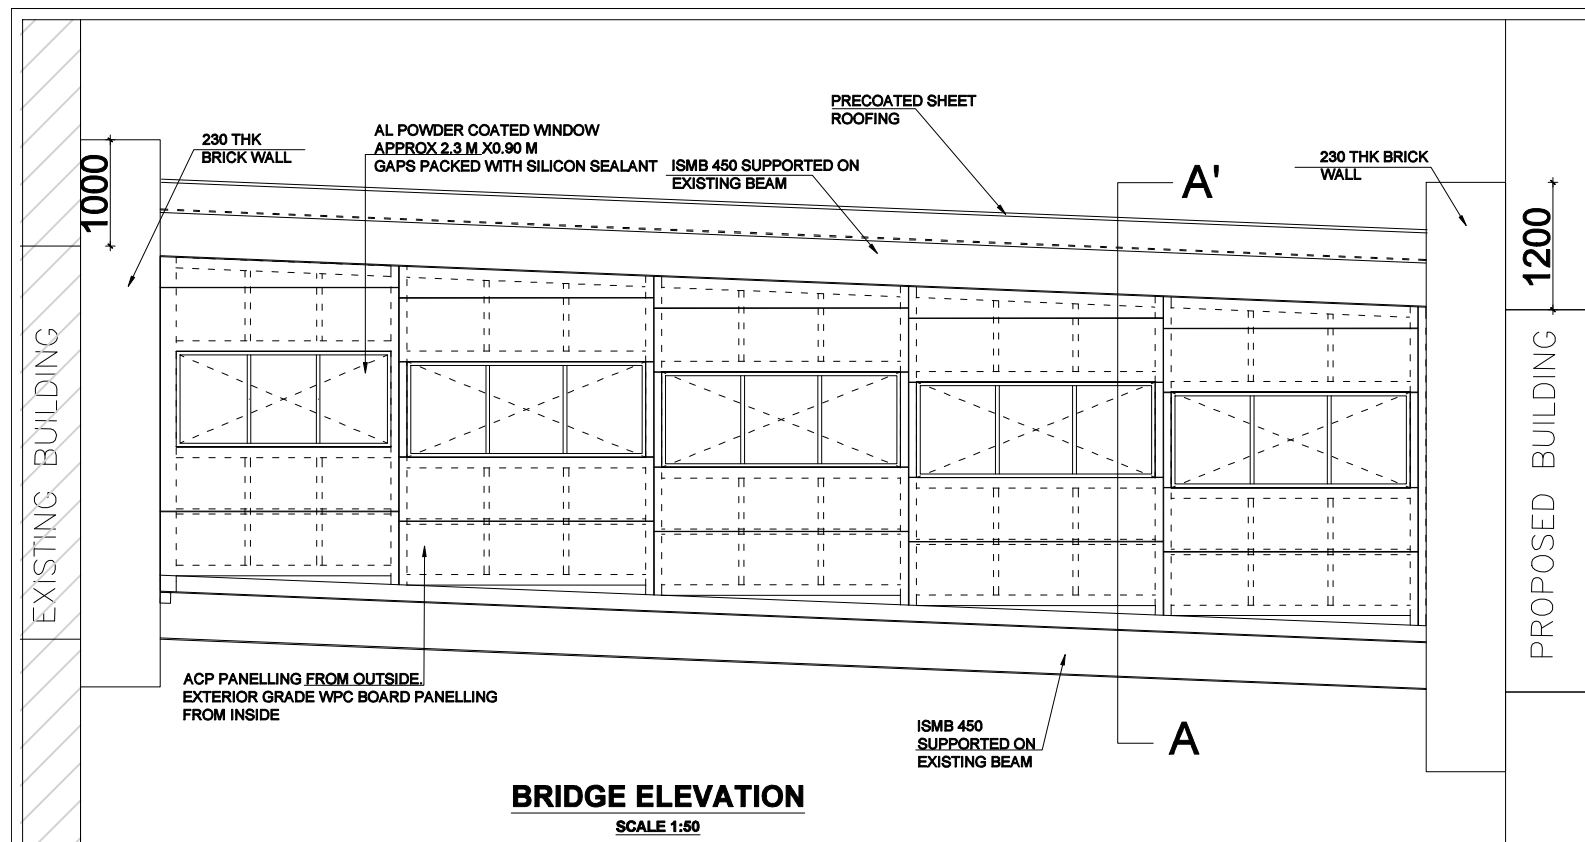

KEY ELEVATION

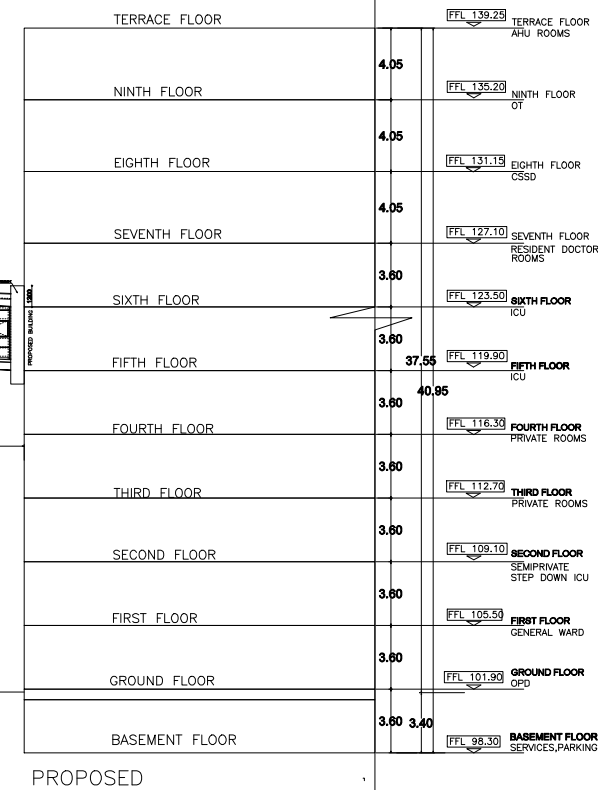


PROPOSED

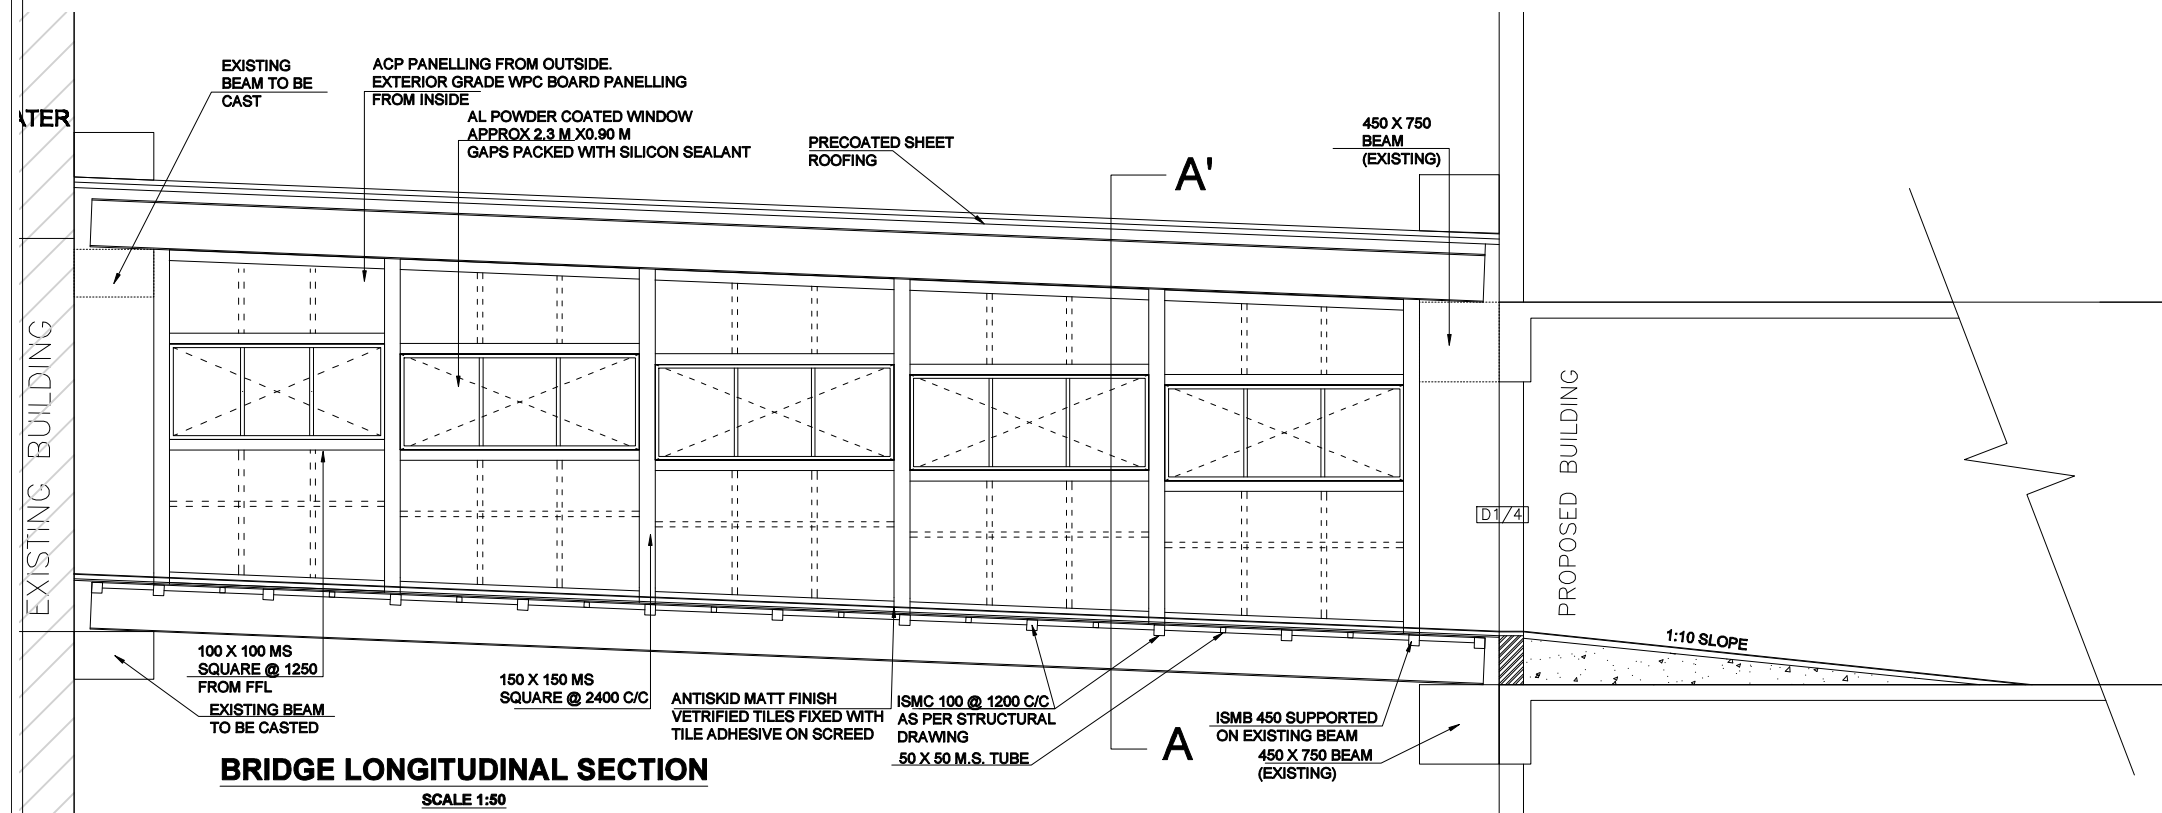


BRIDGE LONGITUDINAL SECTION

SCALE 1:50

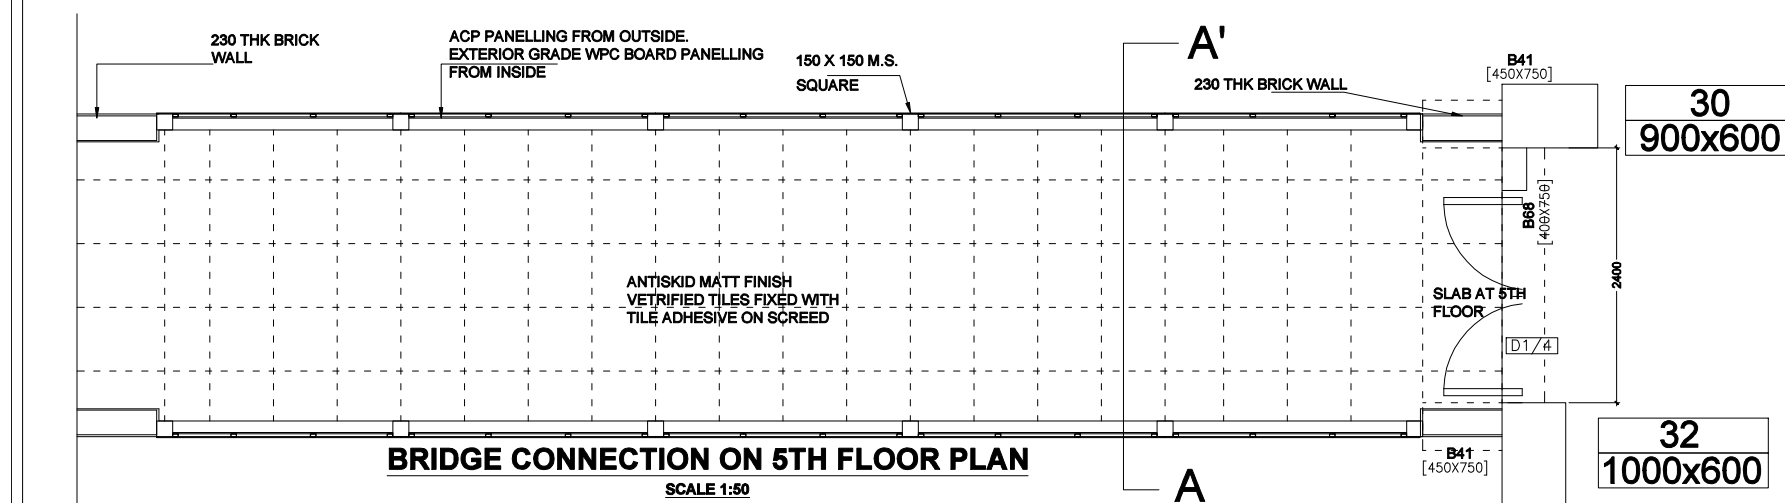

BRIDGE CONNECTION ON 5TH FLOOR PLAN

SCALE 1:50

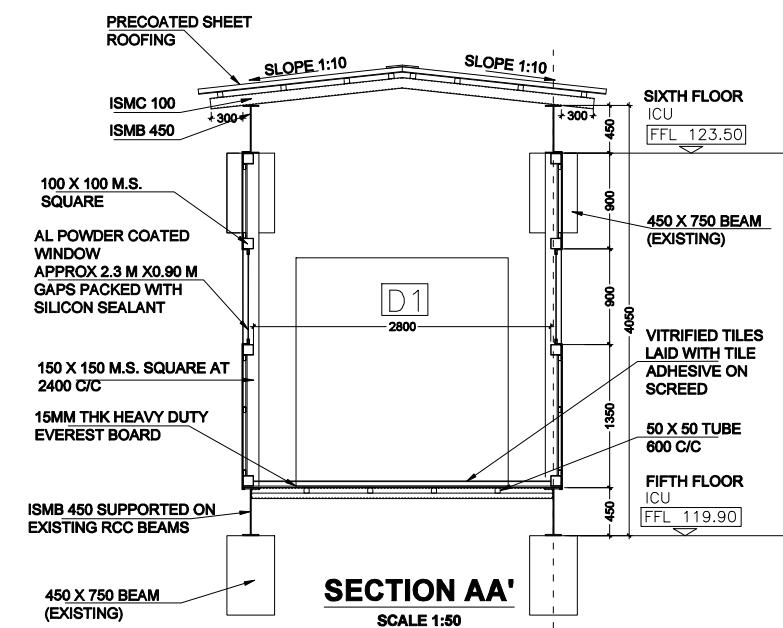

NORTH

- NOTES -
- 1.Do not scale the drawing.Work to figured dimensions only.
 - 2.All dimensions are in millimetres(mm) unless noted otherwise & levels in metres(m).
 - 3.This drawing to be read in conjunction with all relevant contract drawings and documentation.
 - 4.This drawing is to be carefully checked by contractor against architects drawings,and any discrepancy reported to the engineer before construction commences.

ARCHITECT -

ARCHITECTS UNITED

Address: 111/3,14th lane prabhat road, Pune-411004.
Tel: 020-25441426, 020-25469176 Fax: 020-25448059.
E-mail: architectsunitied@vsnl.net
Website: www.architectsunitied.com

PROJECT -

CONNECTION BRIDGE AT HOSPITAL at F.P
NO.19/2, Pachha Peth, Solapur-413005

CLIENT - SHRI MARKANDEY SAHANKARI RUGNALAYA
& RESEARCH CENTER NIYAMIT.

SCALE	DATE	DRAWN BY	JOB NO	STATUS
1:50	13.05.23	SIDDHI K	16_20_S11	FOR TENDER

DRAWING NAME-	REVISIONS
BRIDGE_DETAIL-OPTION 2	RO
FILE NAME-BRIDGE_16_20_S11	
DRAWING NO-	